
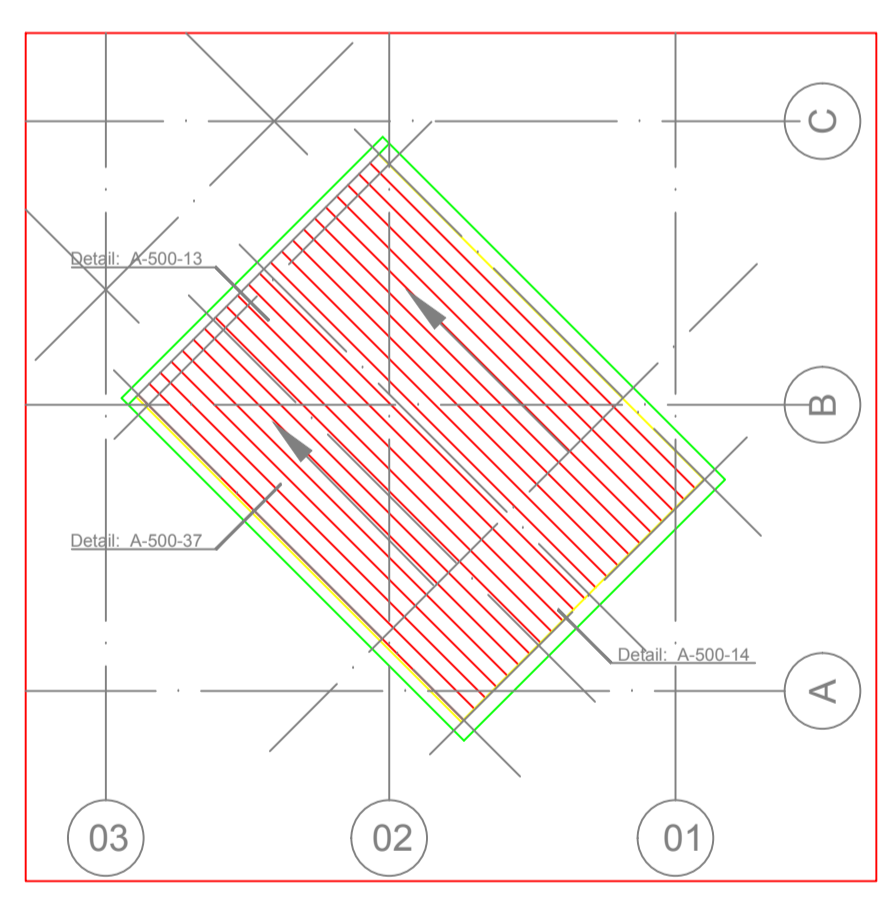
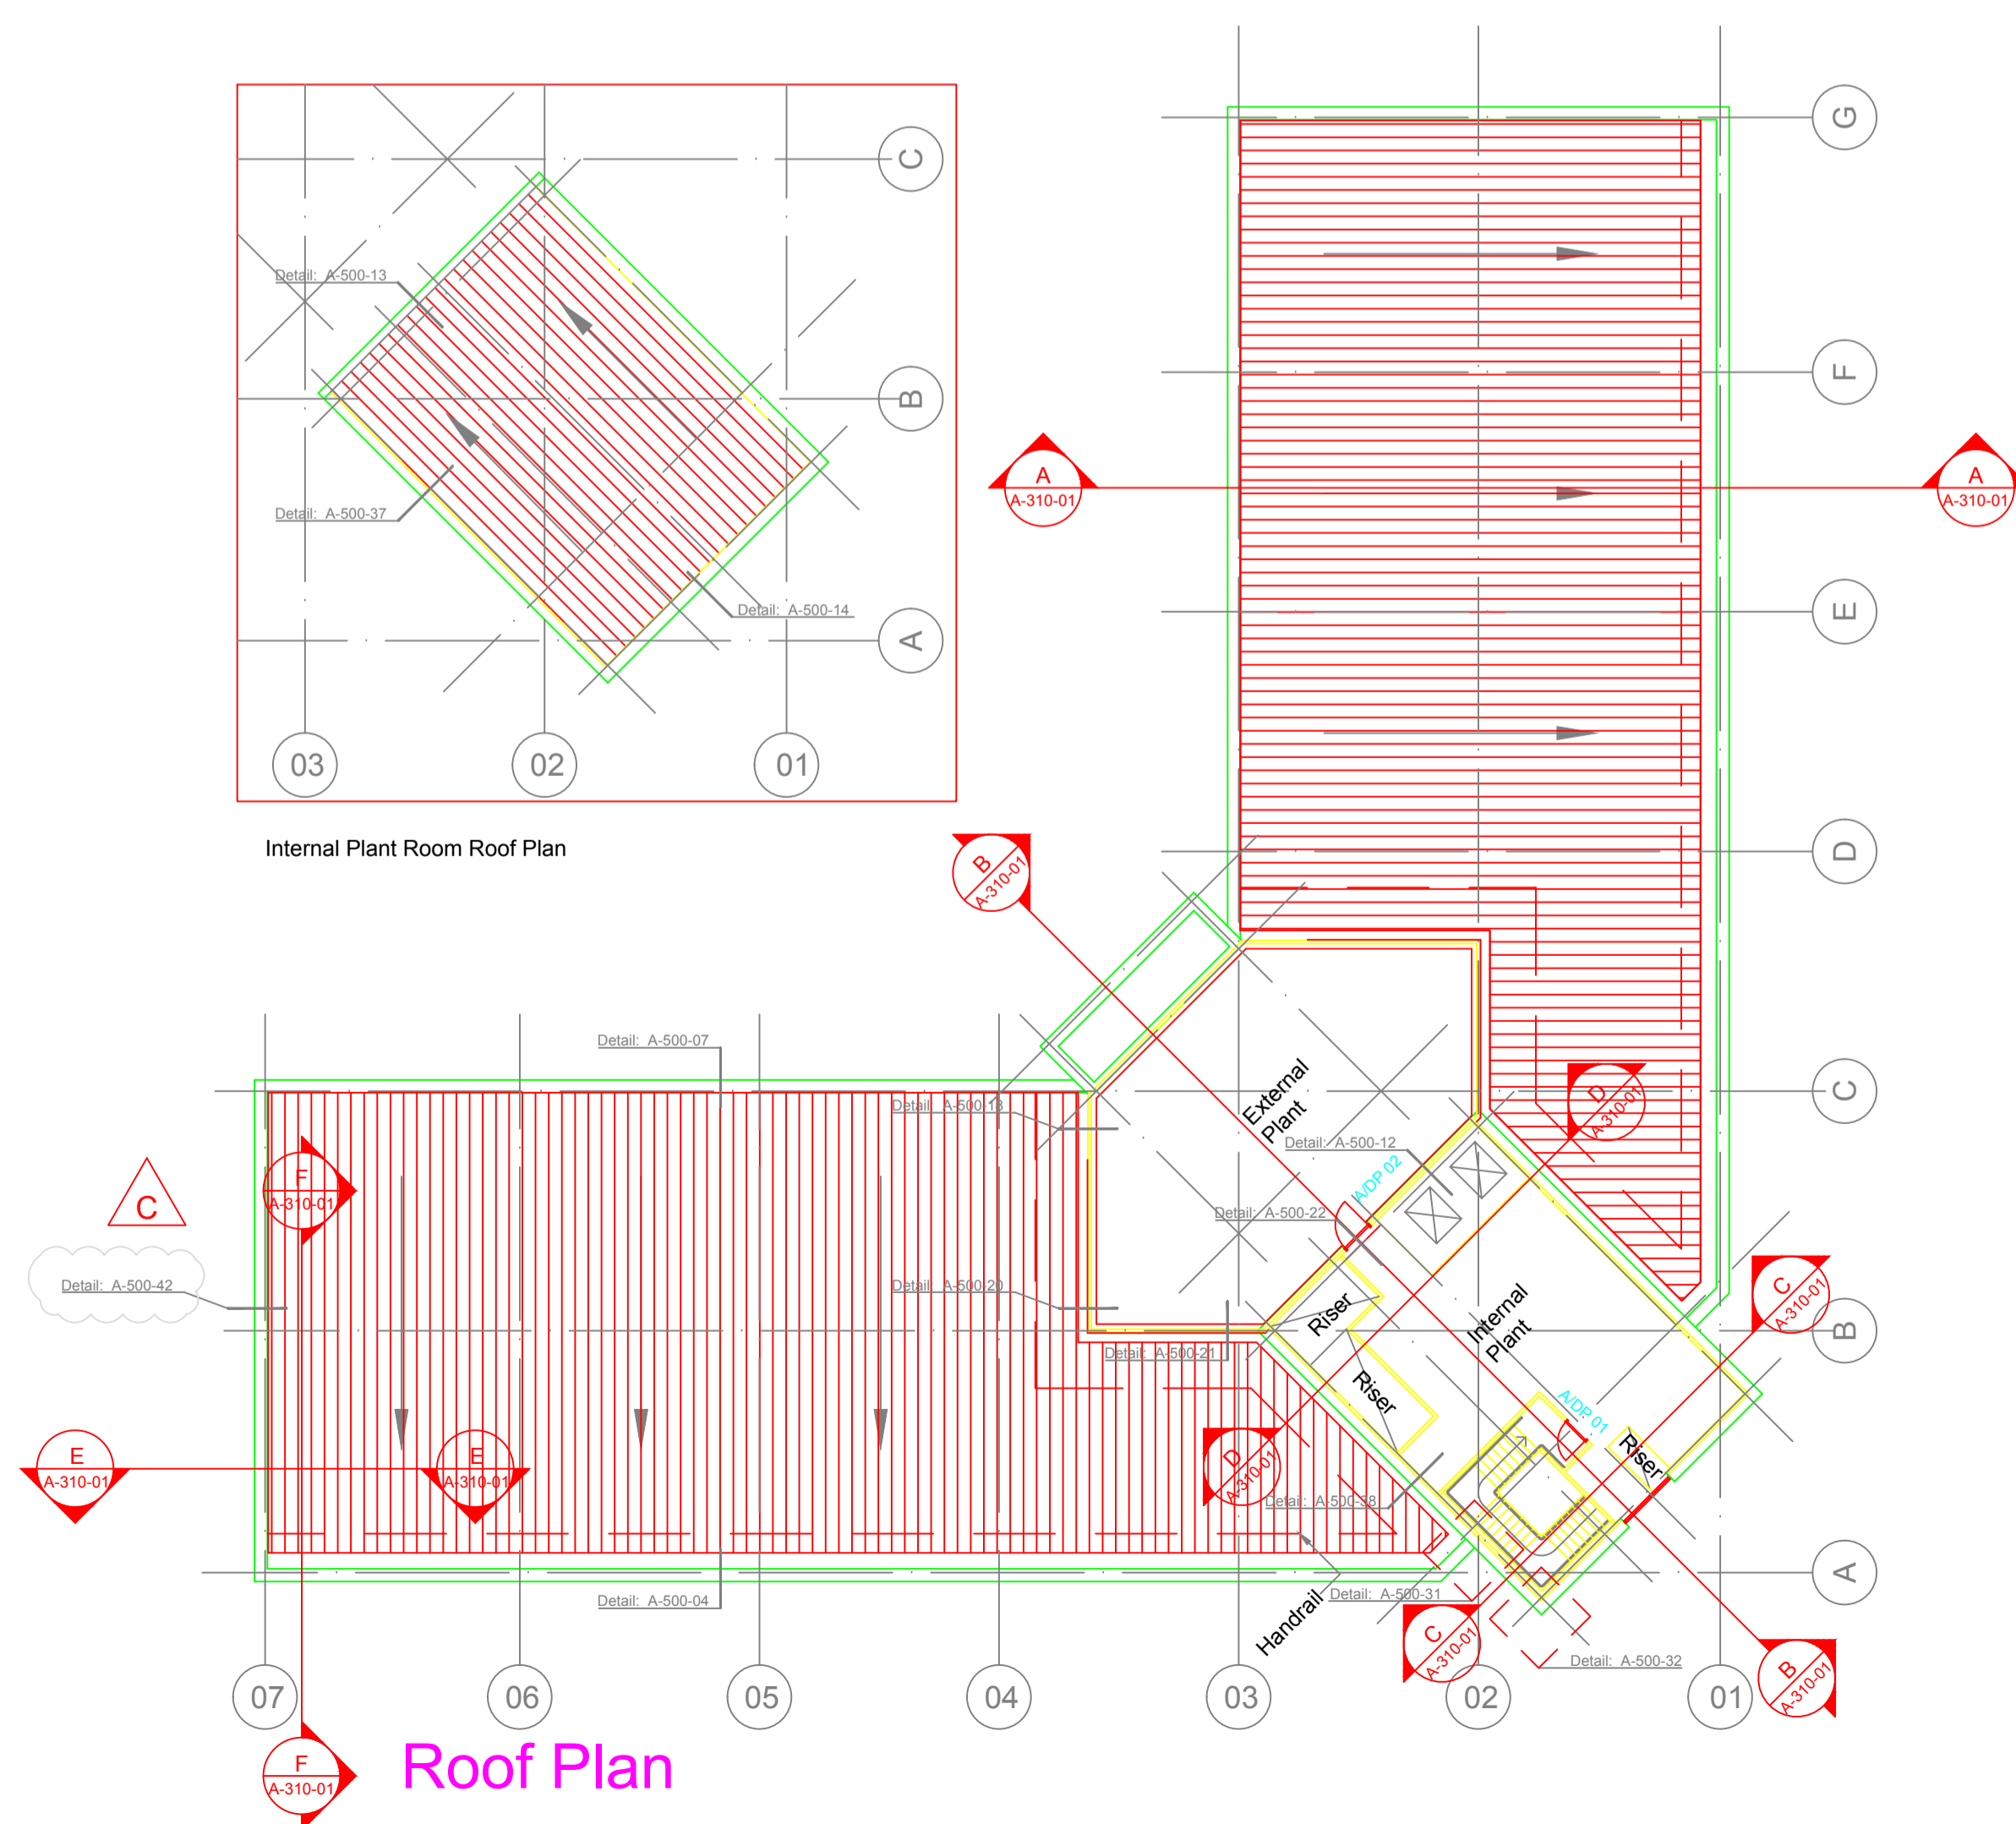
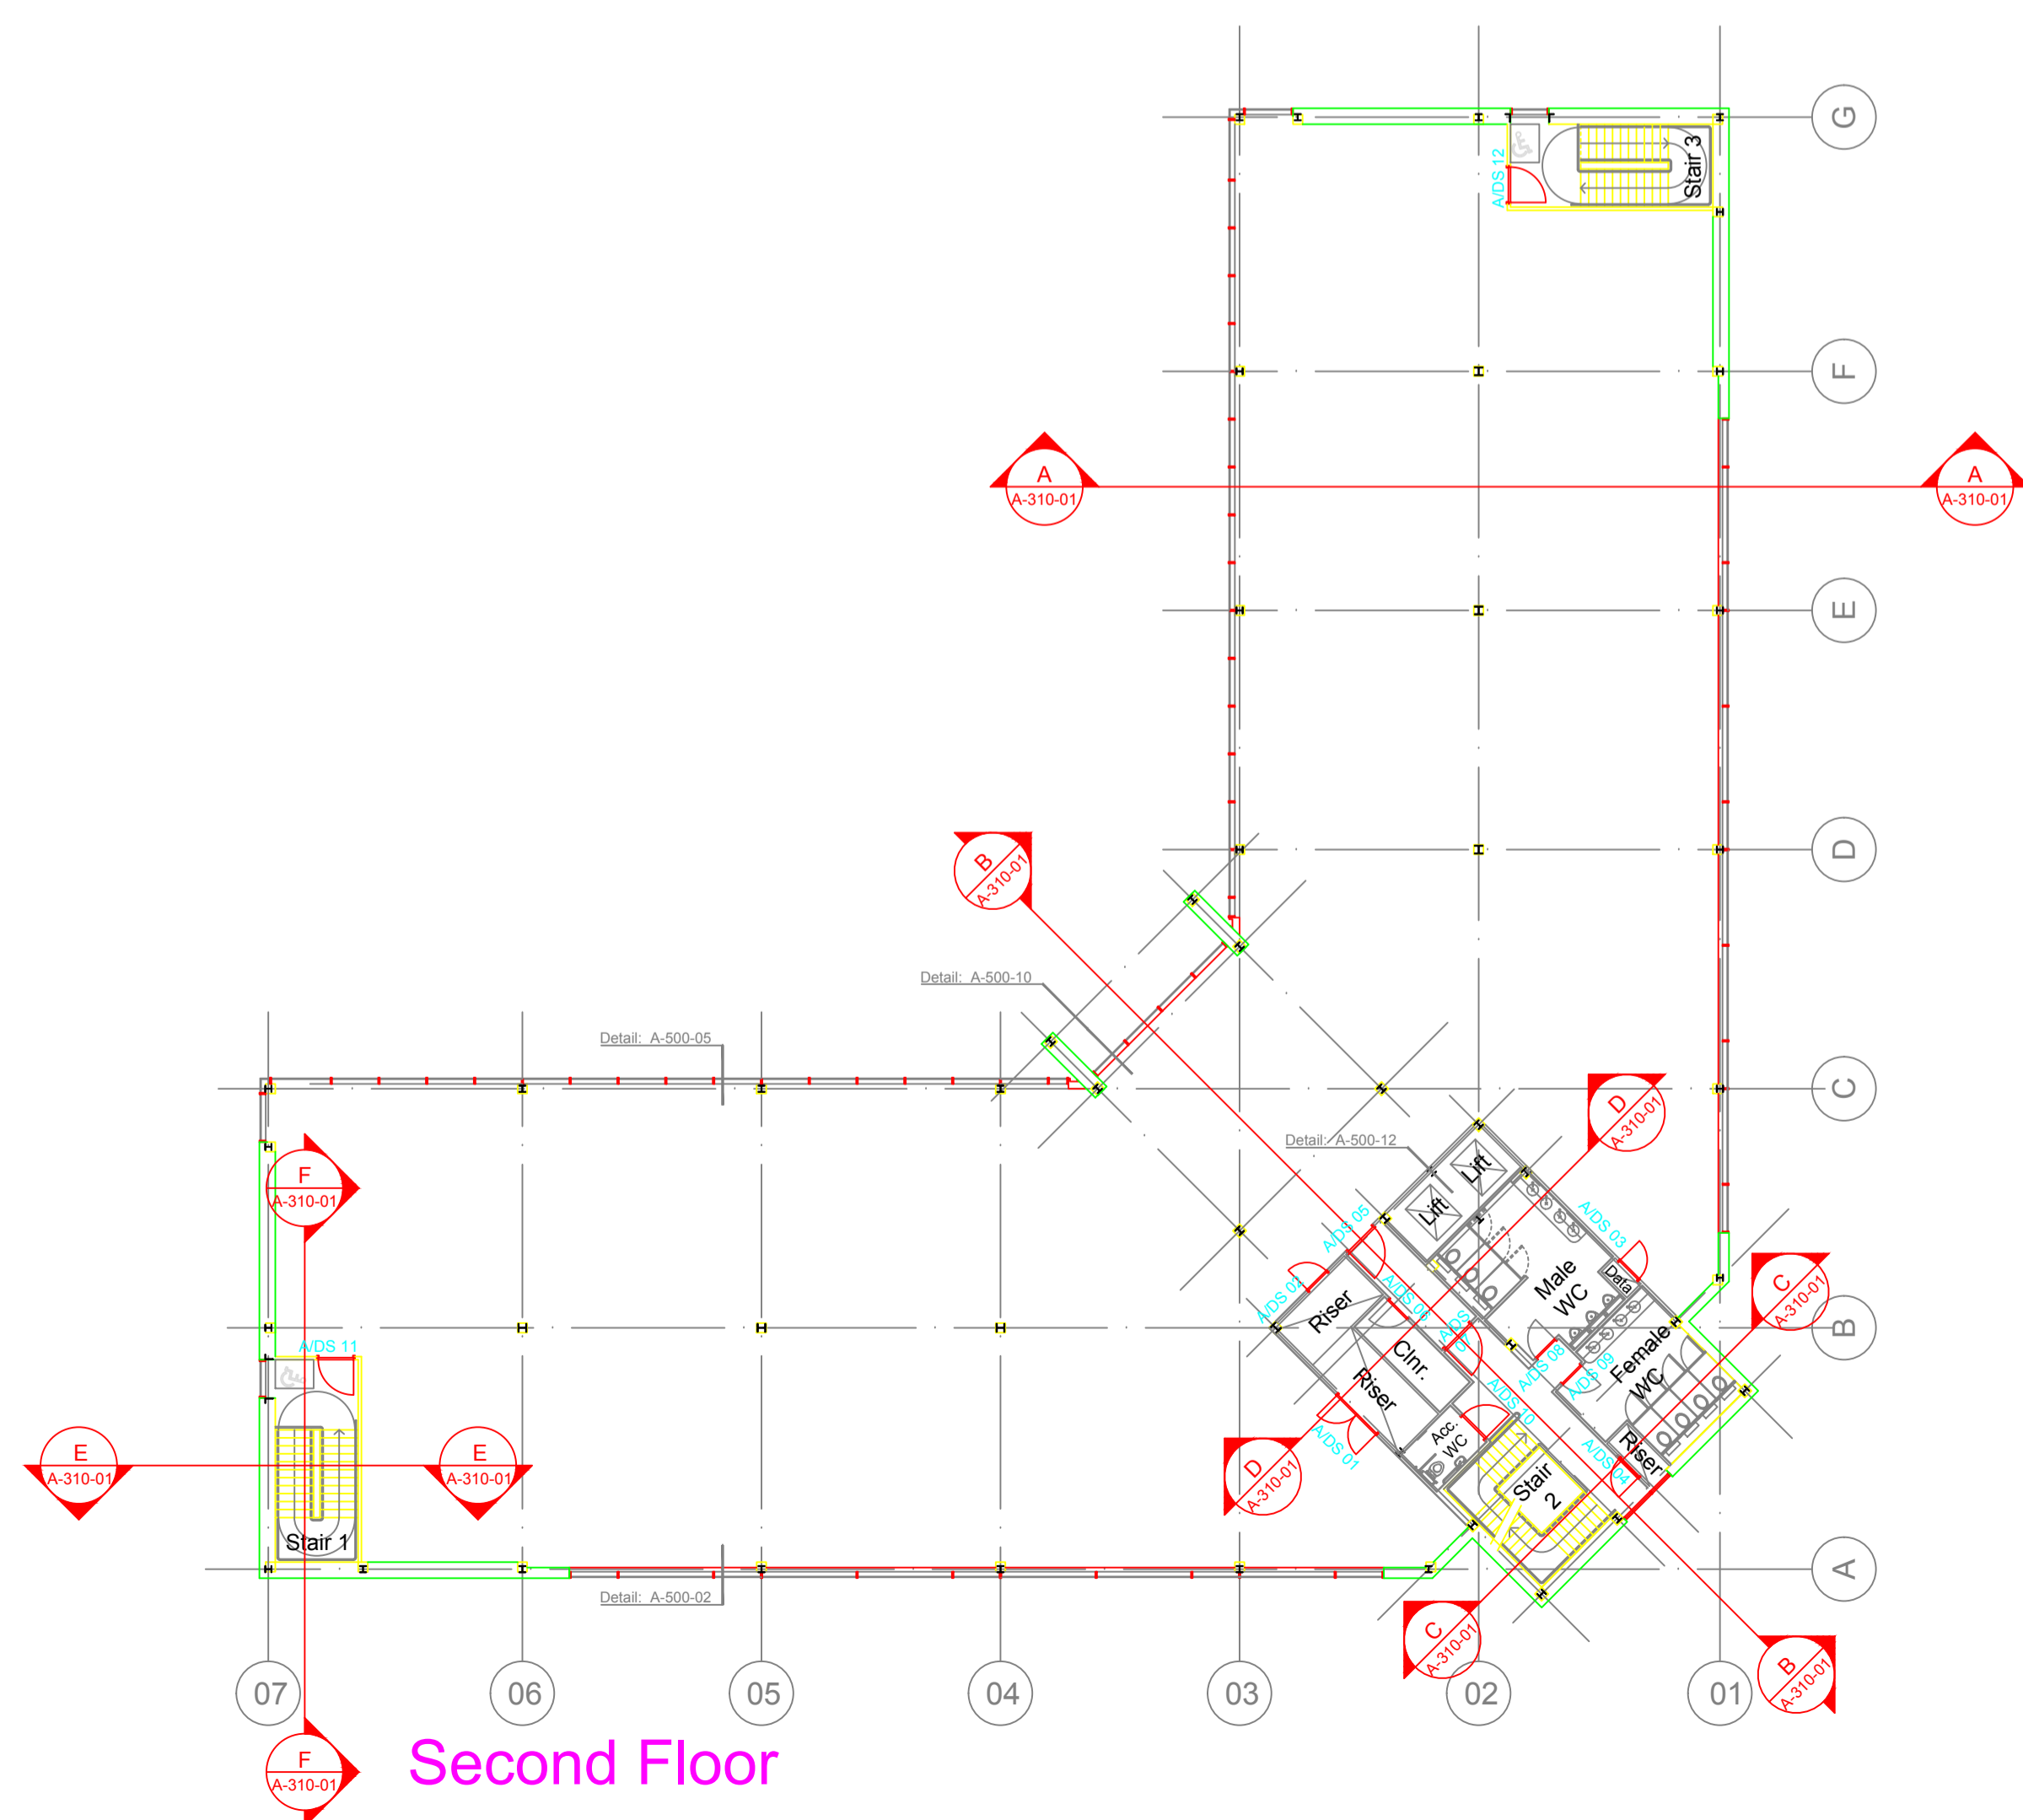
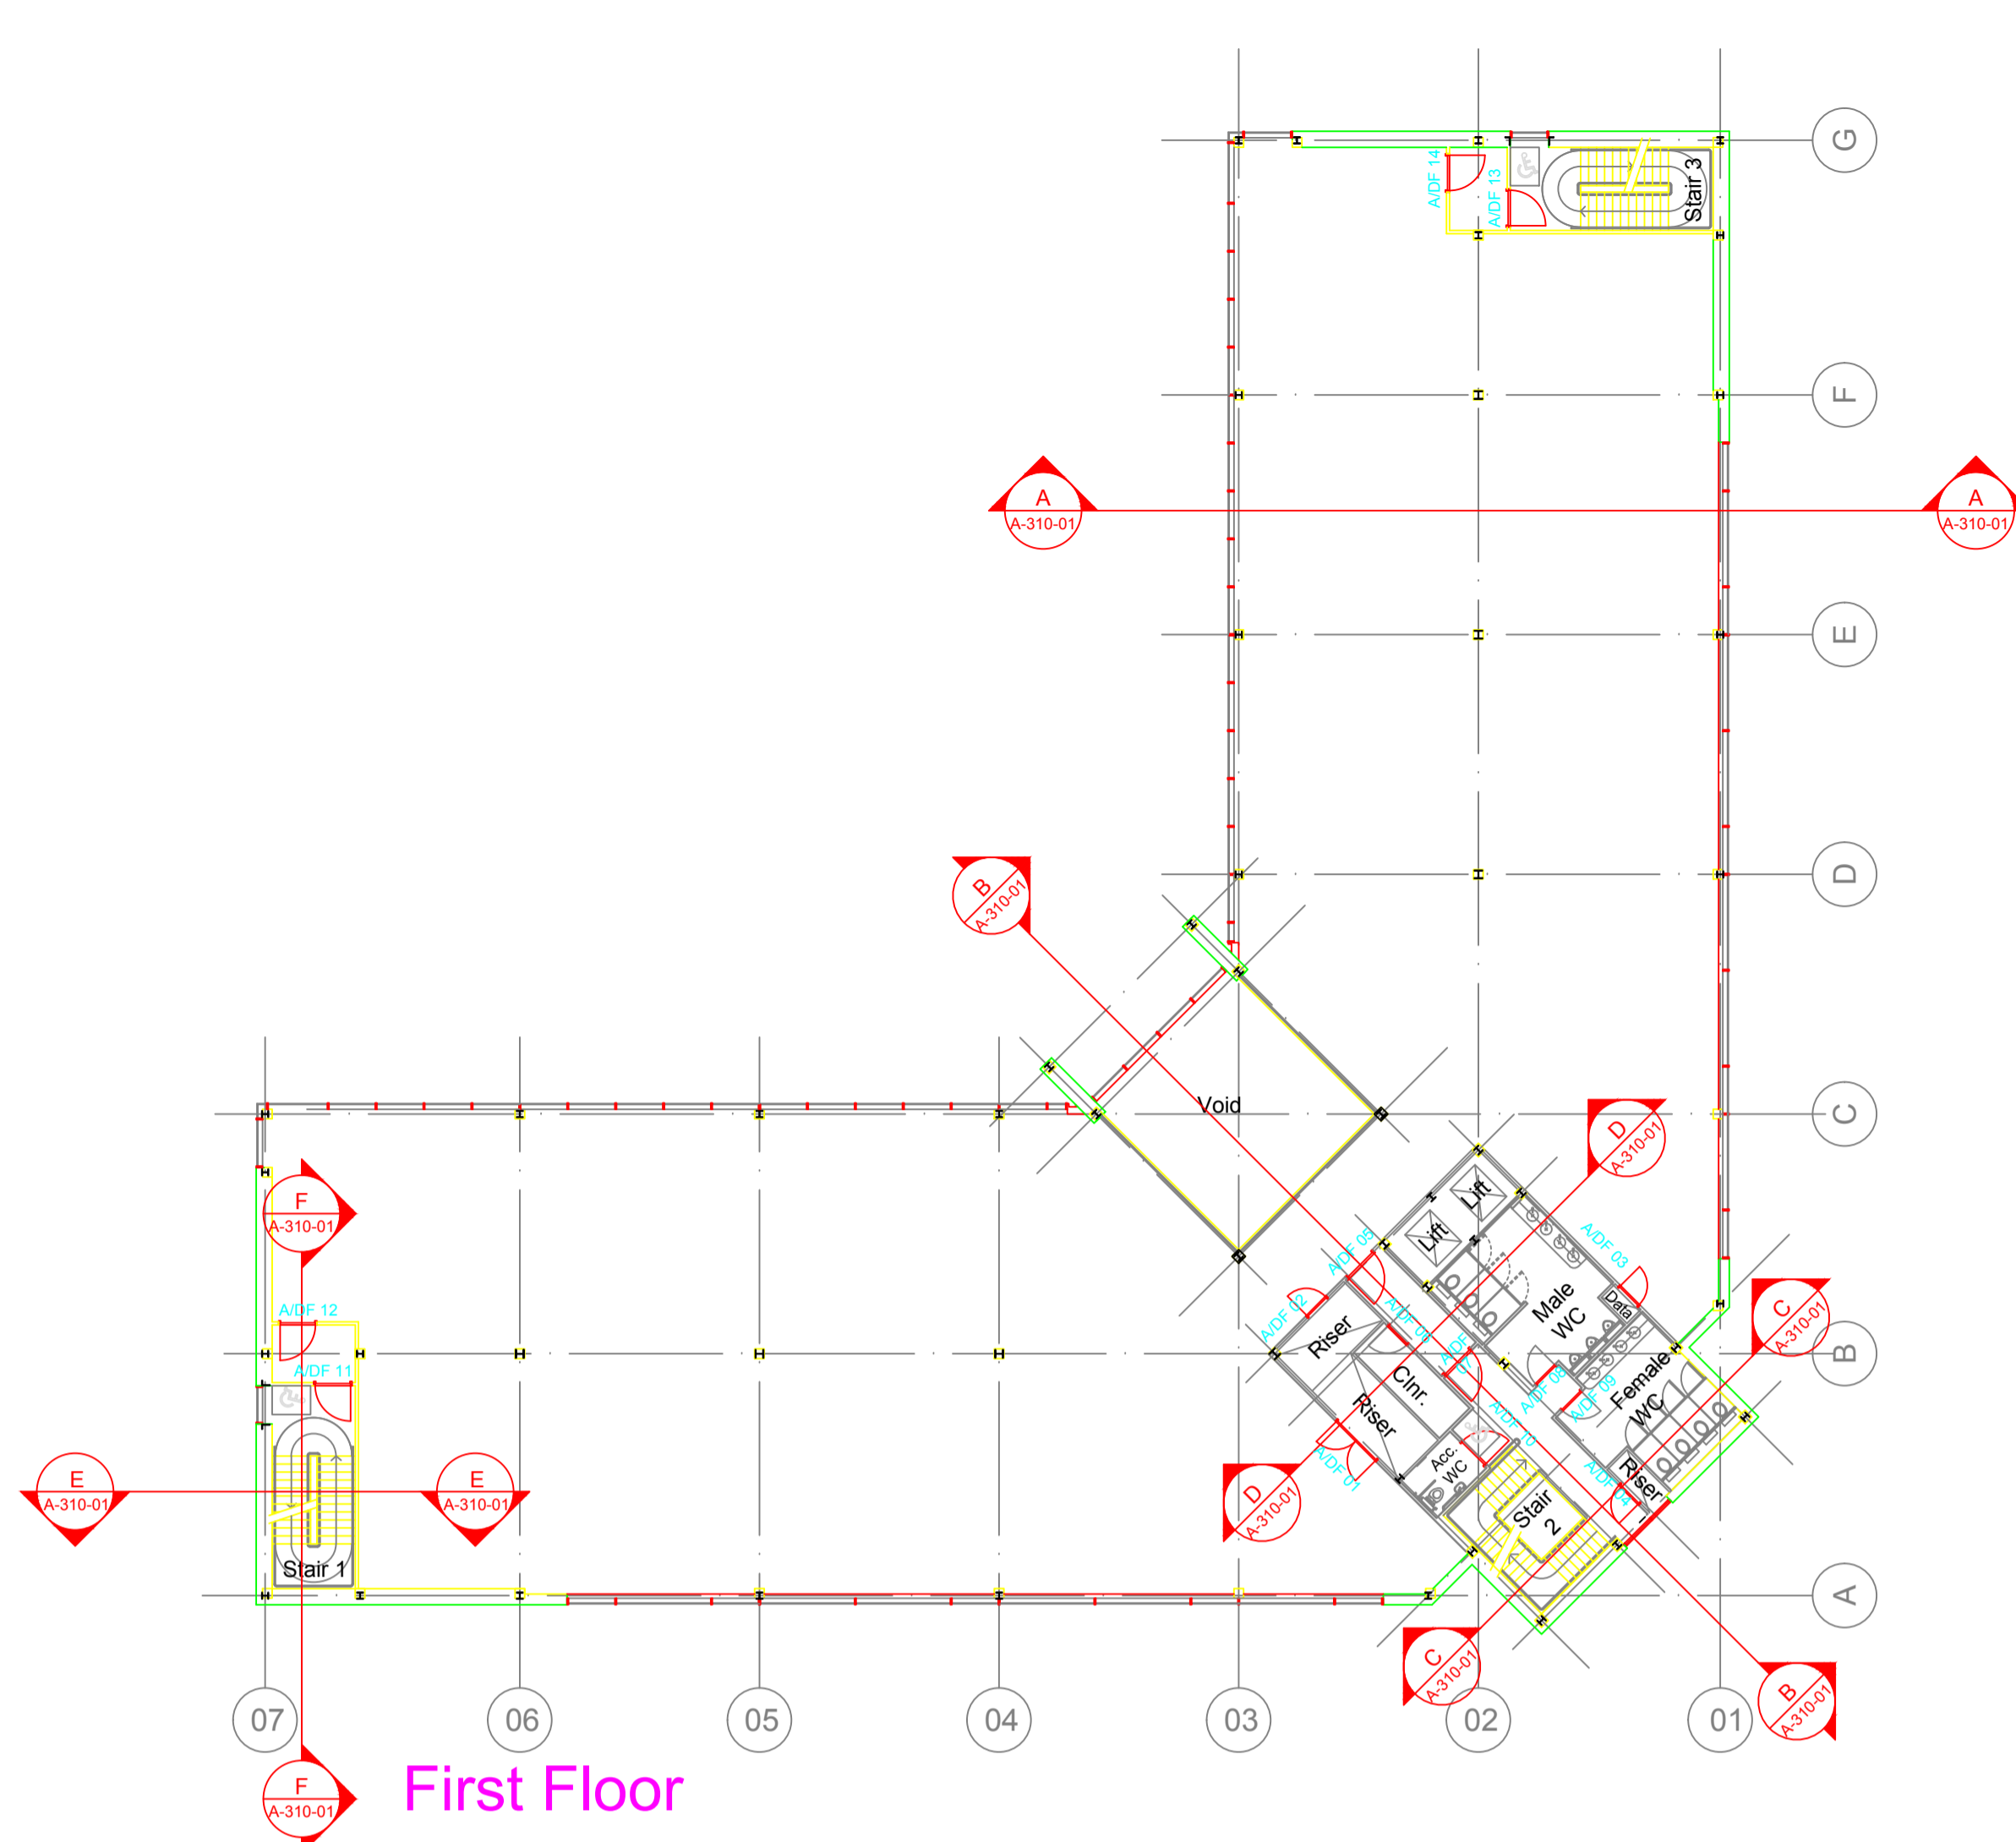


The use of this data by the recipient acts as an agreement of the following statements. Do not use this data if you do not agree with any of the following statements.

All drawings are based upon site information supplied by third parties and as such their accuracy cannot be guaranteed. All features are approximate and subject to clarification by a detailed topographical survey, statutory service enquiries and confirmation of the legal boundaries.

Do not scale the drawing.
Use figured dimensions in all cases.
Check all dimensions on site.

Report any discrepancies in writing to RyderHKS before proceeding.

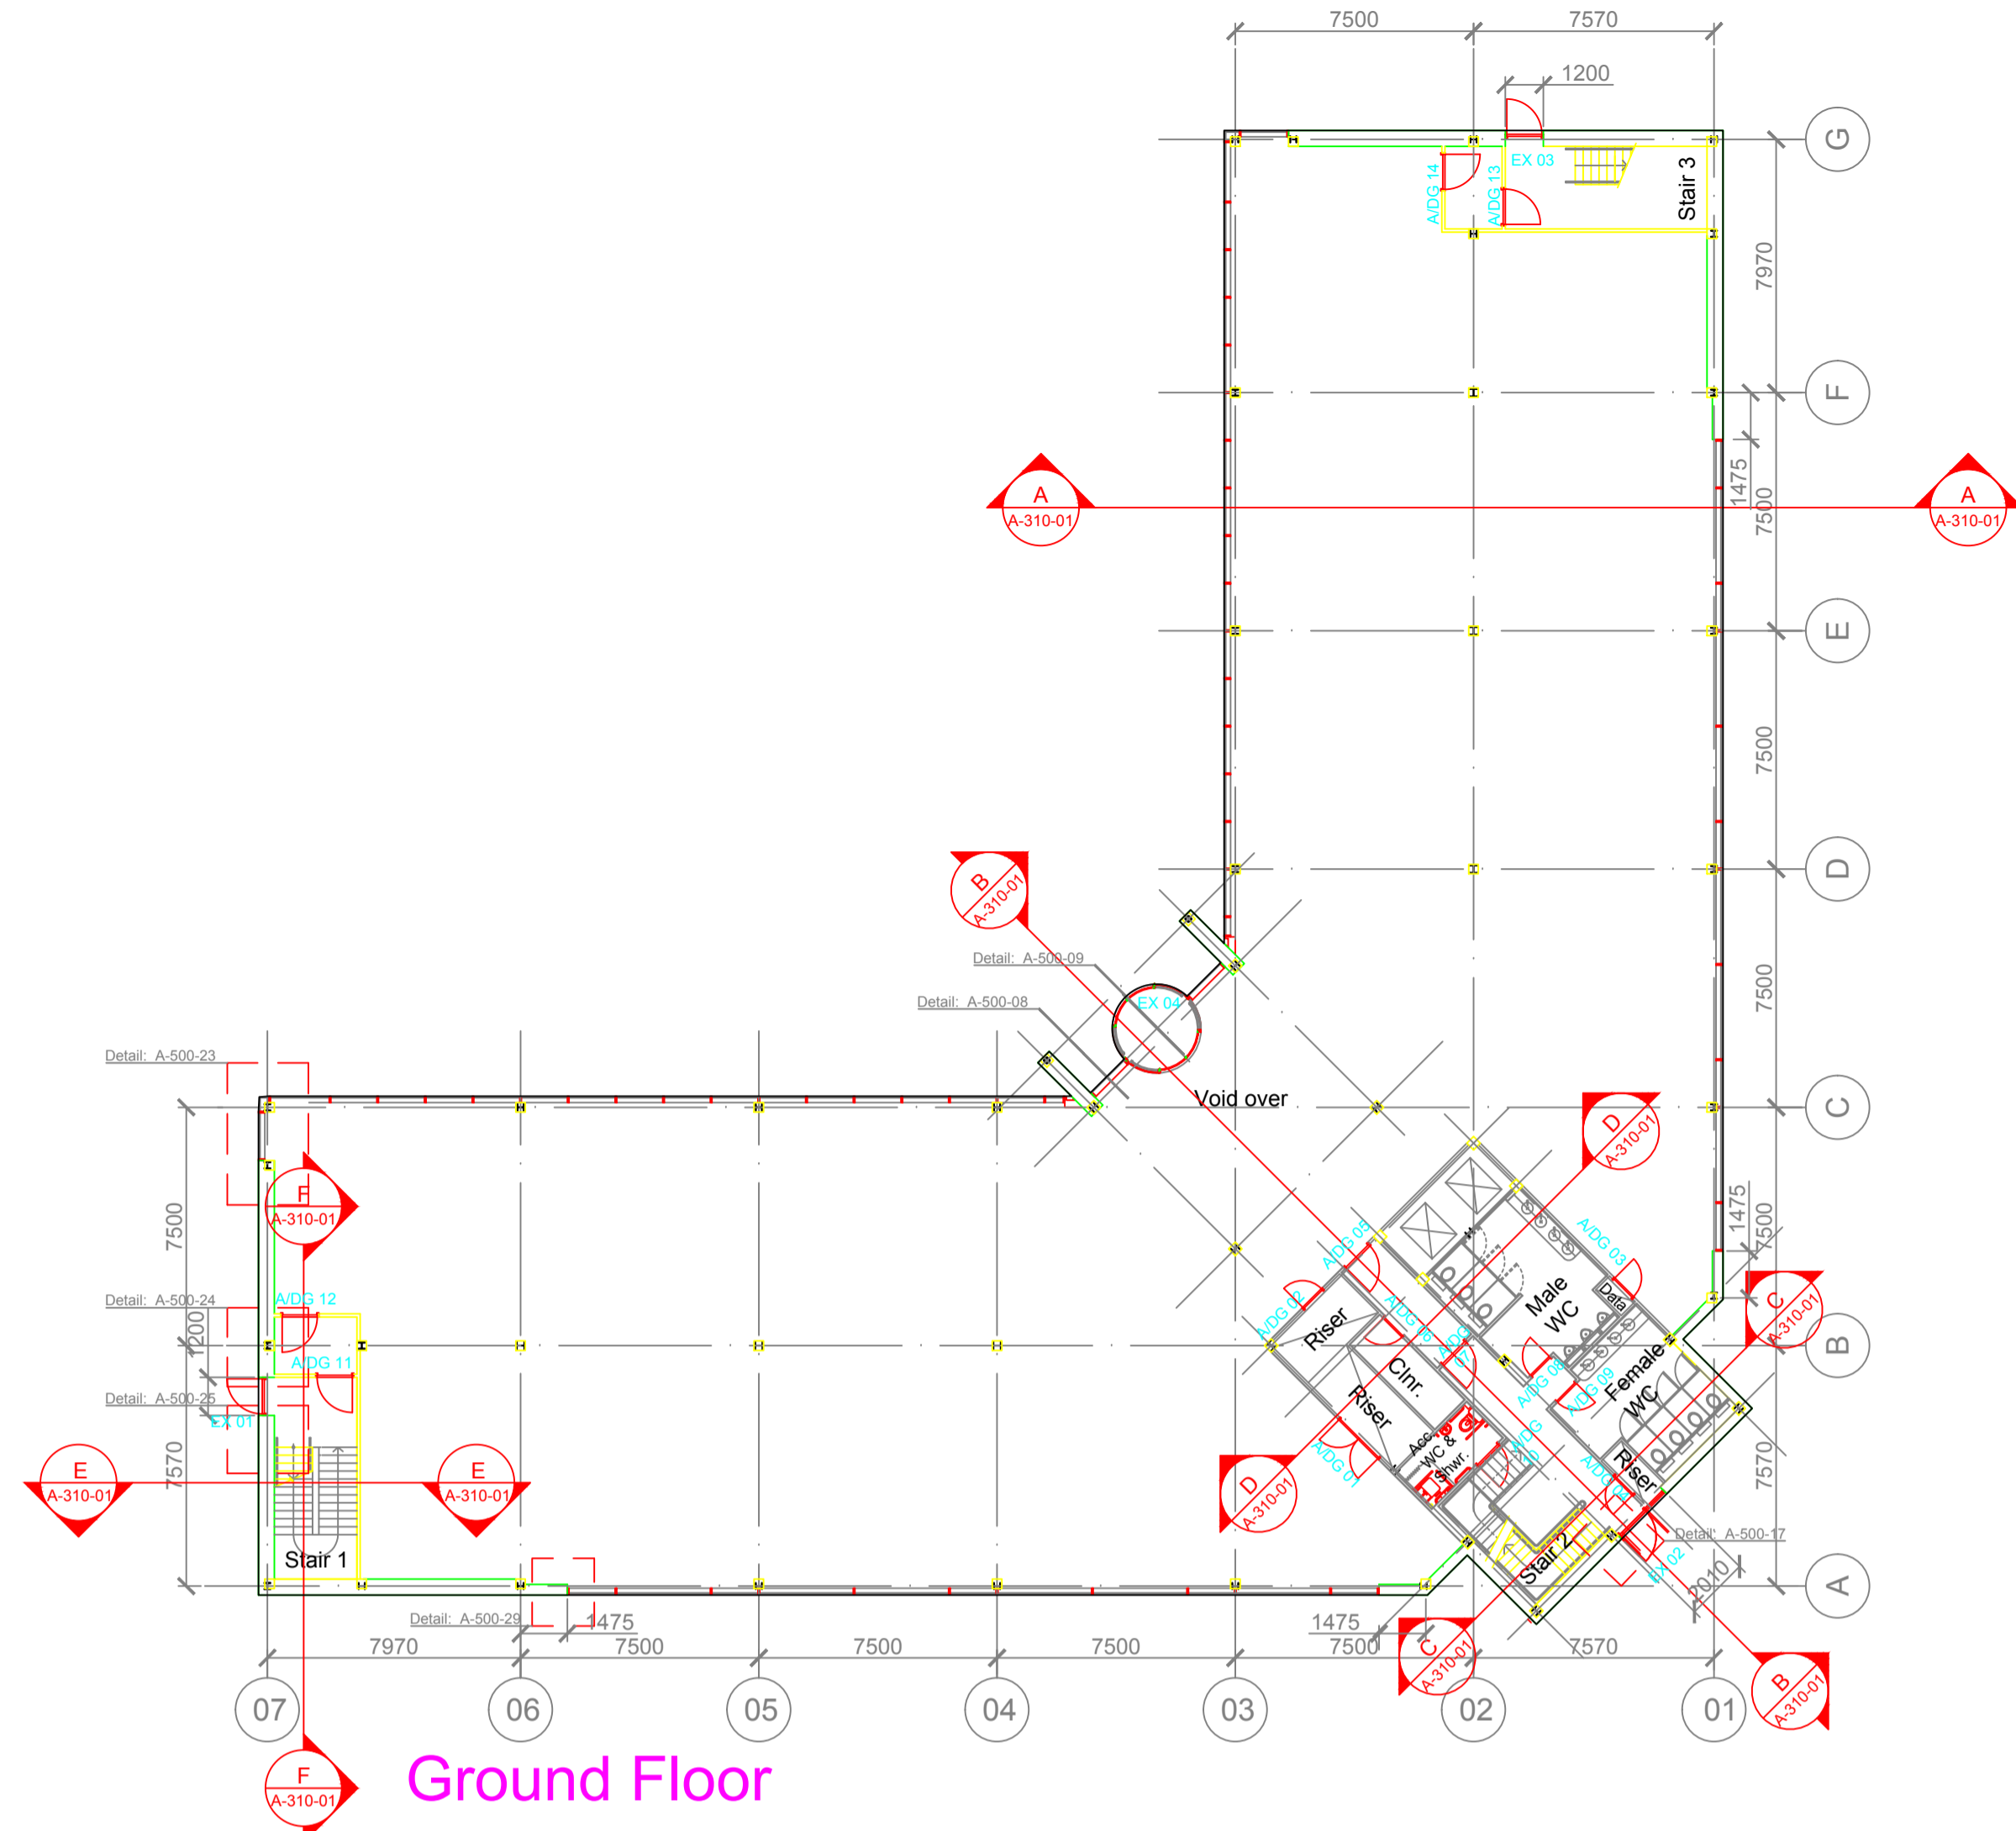

Revision:	Date:	Drawn By:
LCI	19/12/06	GKR
Last Construction Issue		
Revision:	Date:	Drawn By:
C	15/09/05	GTa
Gable Parapet Detail Ref added.		
Revision:	Date:	Drawn By:
B	28/04/06	TGR
Door References added		
Revision:	Date:	Drawn By:
A	29/03/06	TGR
First Construction Issue		
Revision:	Date:	Drawn By:
08	10/02/06	SAy
Inset of Internal Plant room Roof Plan added		
Revision:	Date:	Drawn By:
07	27/01/06	SAy
Detail references added		
Revision:	Date:	Drawn By:
06	31/08/05	MAN
Second floor atrium void removed		
Revision:	Date:	Drawn By:
05	02/06/05	Ath
Section References added		
Revision:	Date:	Drawn By:
04	18/05/05	CYe
Handrail added to roof plan		
Revision:	Date:	Drawn By:
03	11/05/05	Ath
Data riser amended, toilet layouts changed Cavialt removed Acc. Wc & Shower Enlarged		
Revision:	Date:	Drawn By:
02	07/05/05	Ath
Core layout changed- second lift added, stair changed		
Revision:	Date:	Drawn By:
01	05/05/05	Ath
First Issue Carried over from drawing number 1557-161-111 Amendment		
Status		
Last Construction Issue		
Project		
Highbridge Business Park Cobalt 13A North Tyneside		
Drawing		
GA Floor Plans		
Project No:	Drawing No:	Revision
1557	A-200-01	LCI
Scale at A1	Drawn By:	
1:200	Ath	